




1 GROUND FLOOR PLAN (SEWER AND DRAINAGE LAYOUT)  
 P-1 SCALE 1:100 m.

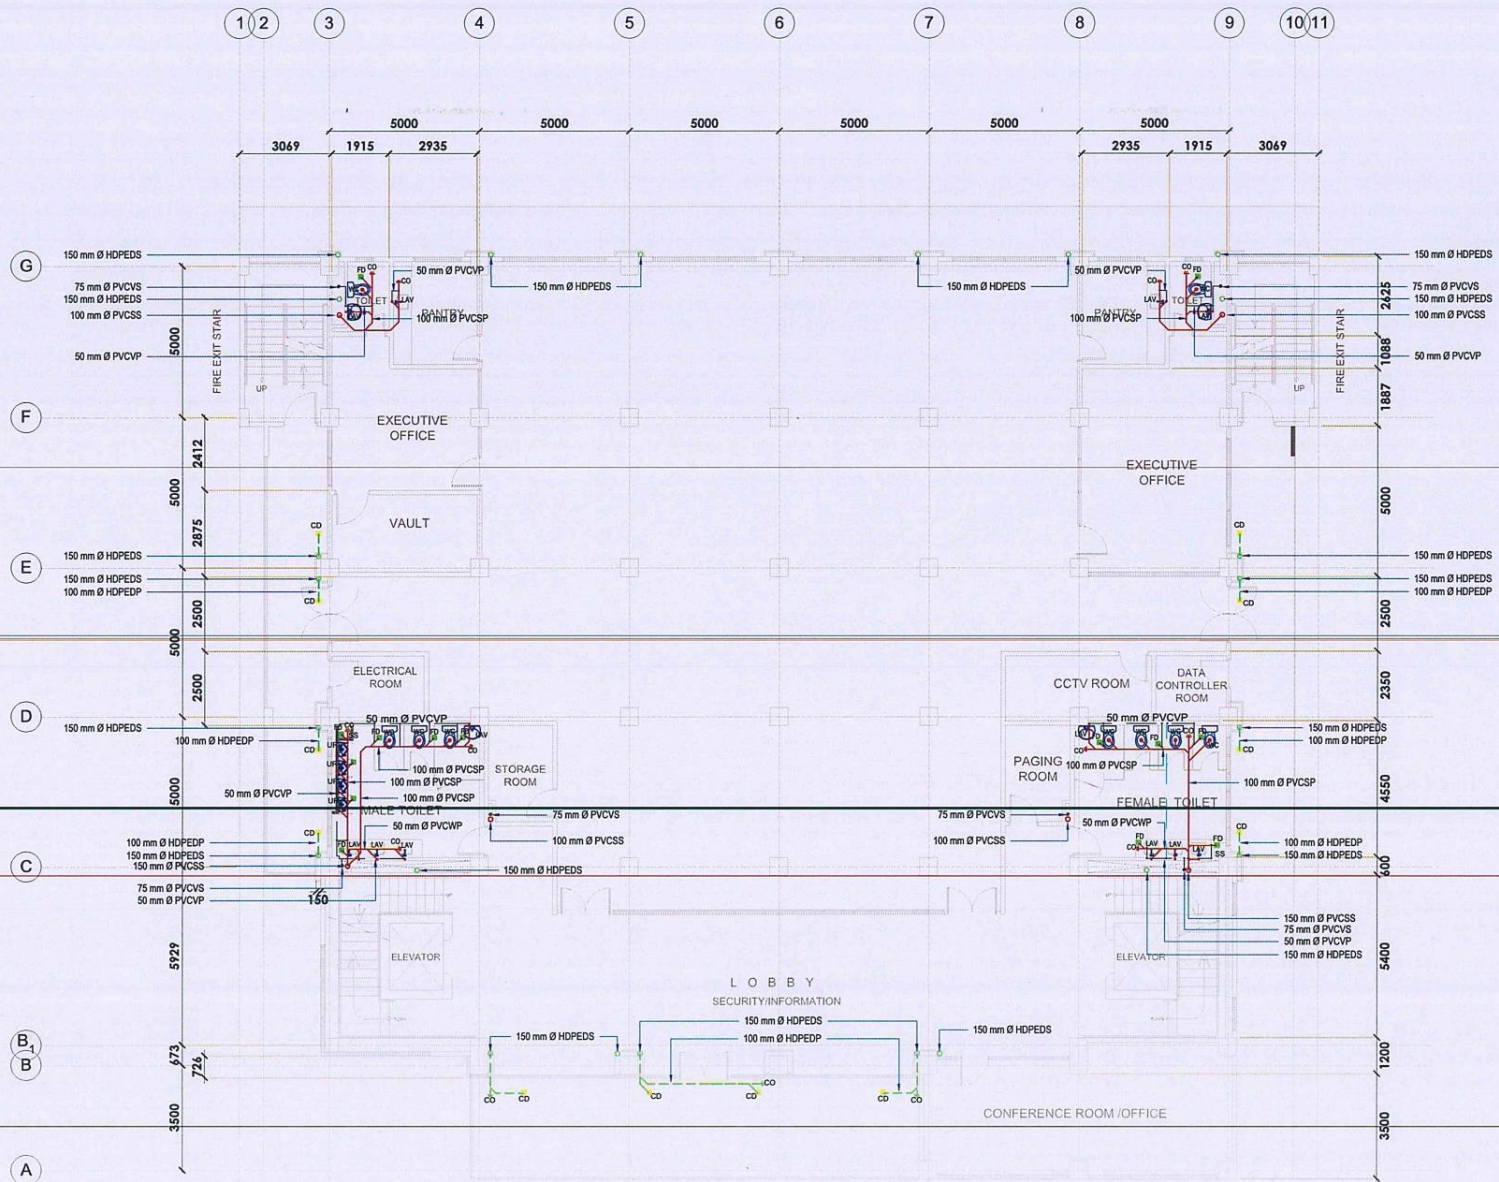


**1 SECOND FLOOR PLAN (SEWER AND DRAINAGE LAYOUT)**  
 P-2 SCALE 1:100 m.

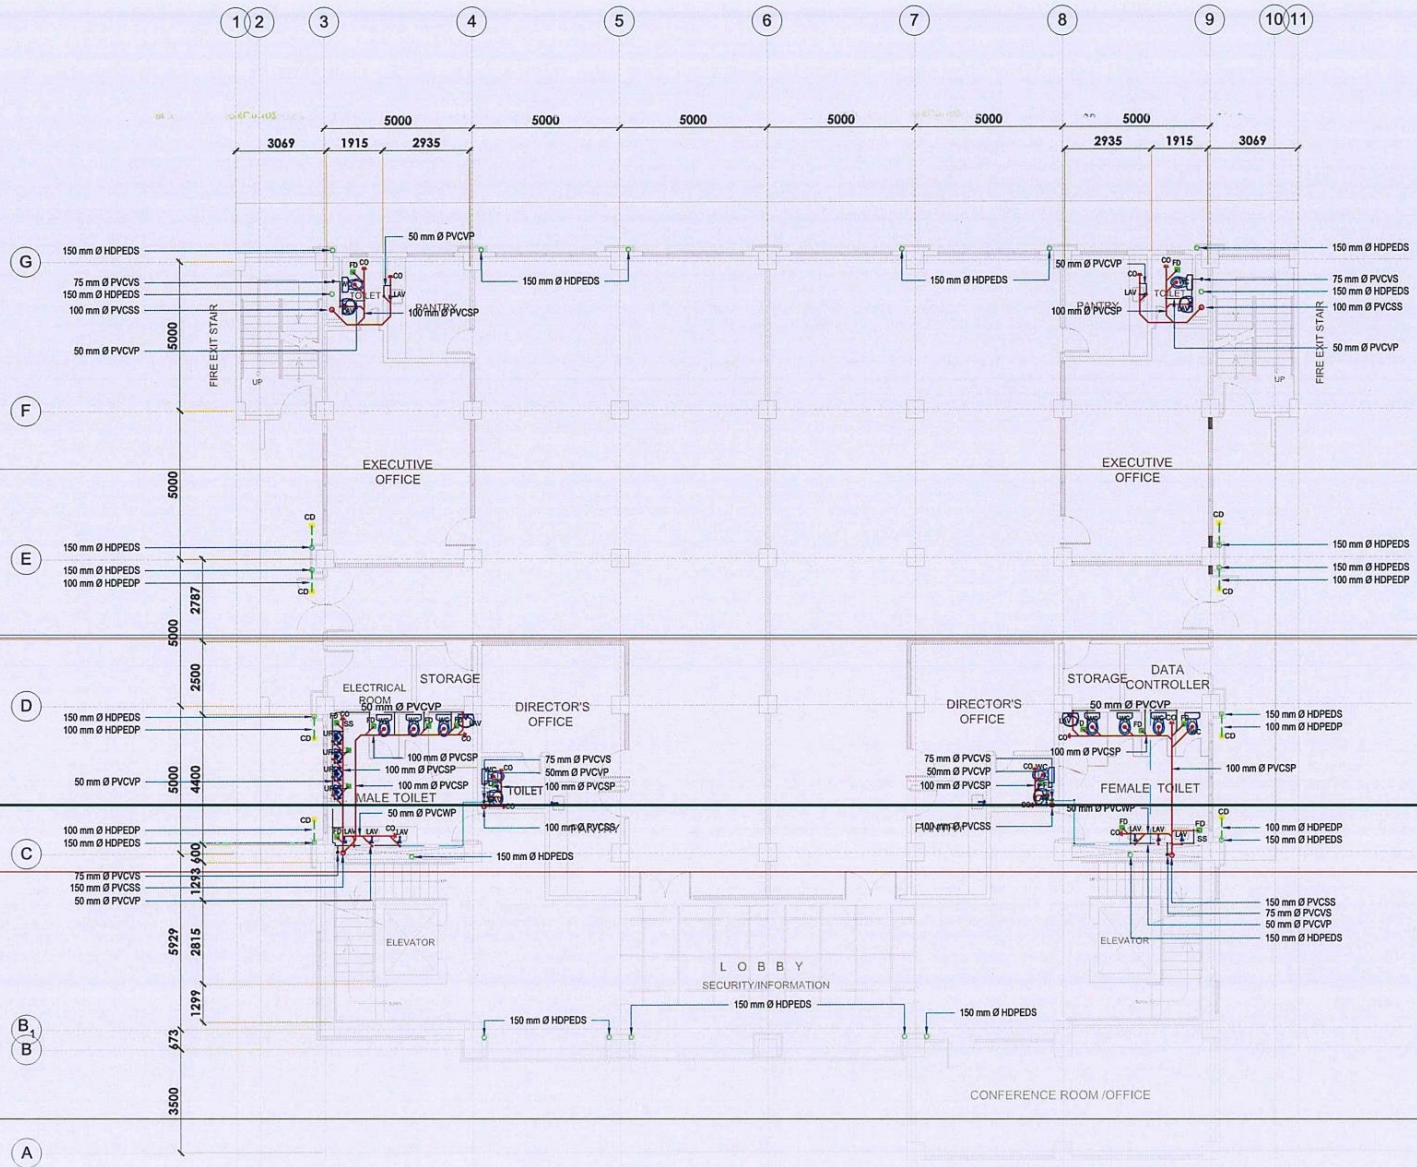

1 THIRD FLOOR PLAN (SEWER AND DRAINAGE LAYOUT)  
 P-3 SCALE 1:100 m.

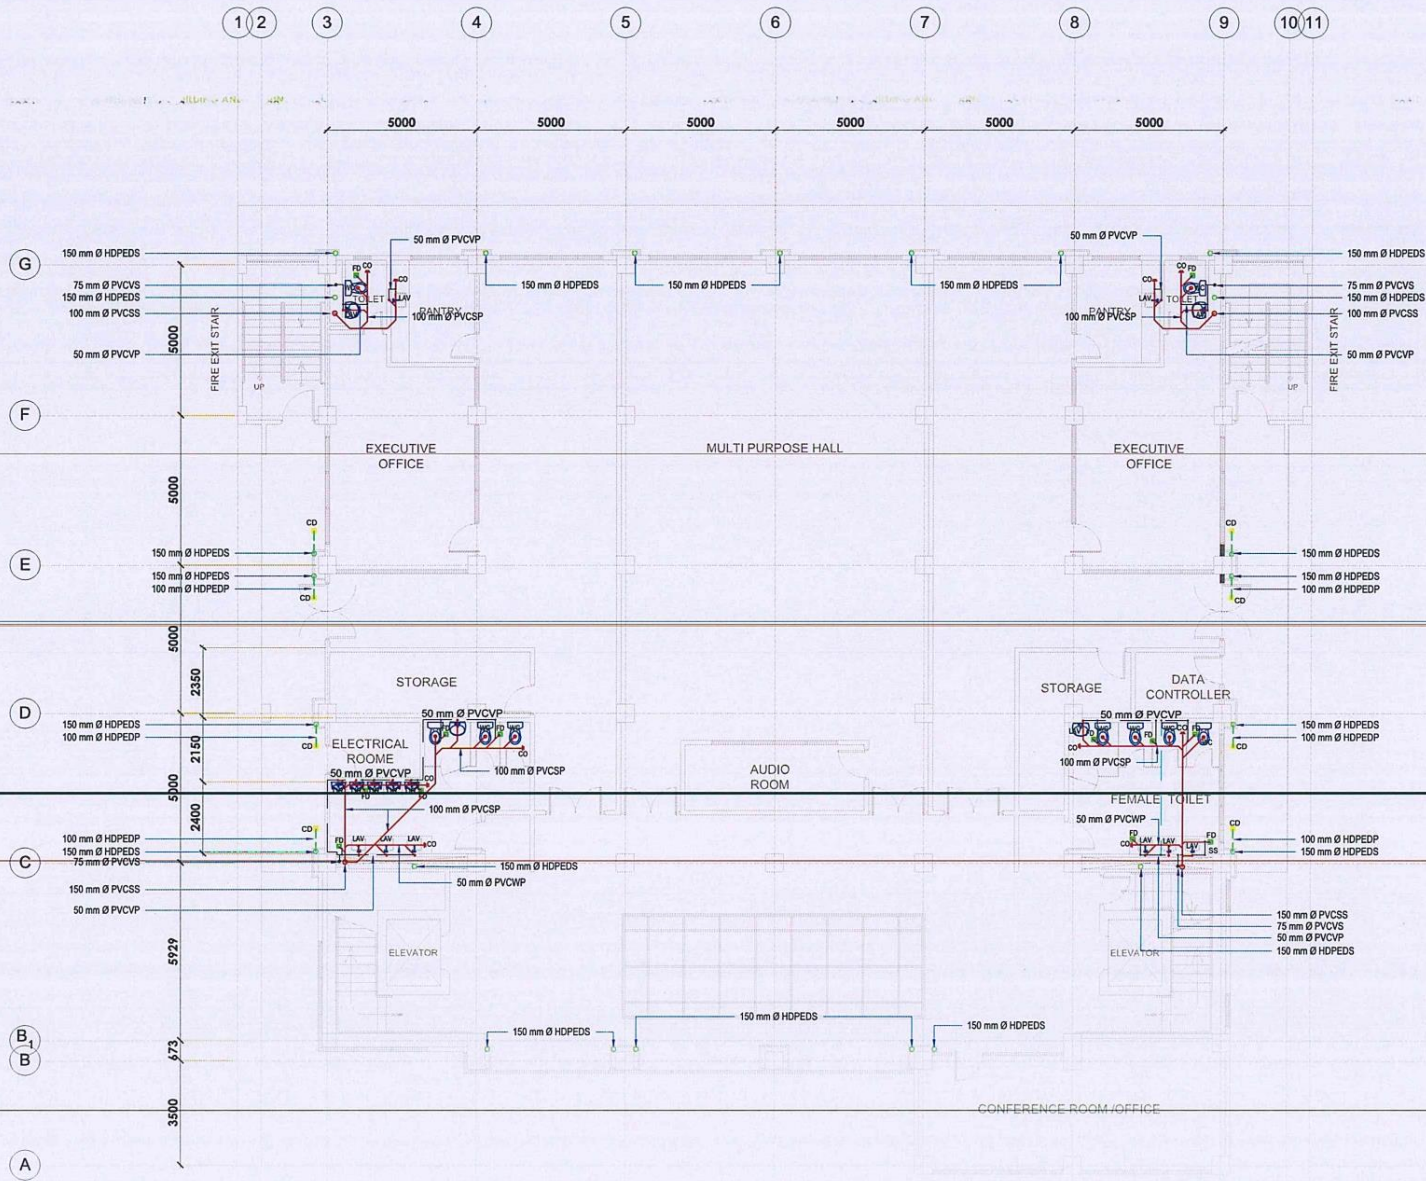

**1** FOURTH FLOOR PLAN (SEWER AND DRAINAGE LAYOUT)  
 P-4  
 SCALE  
 1:100 m.

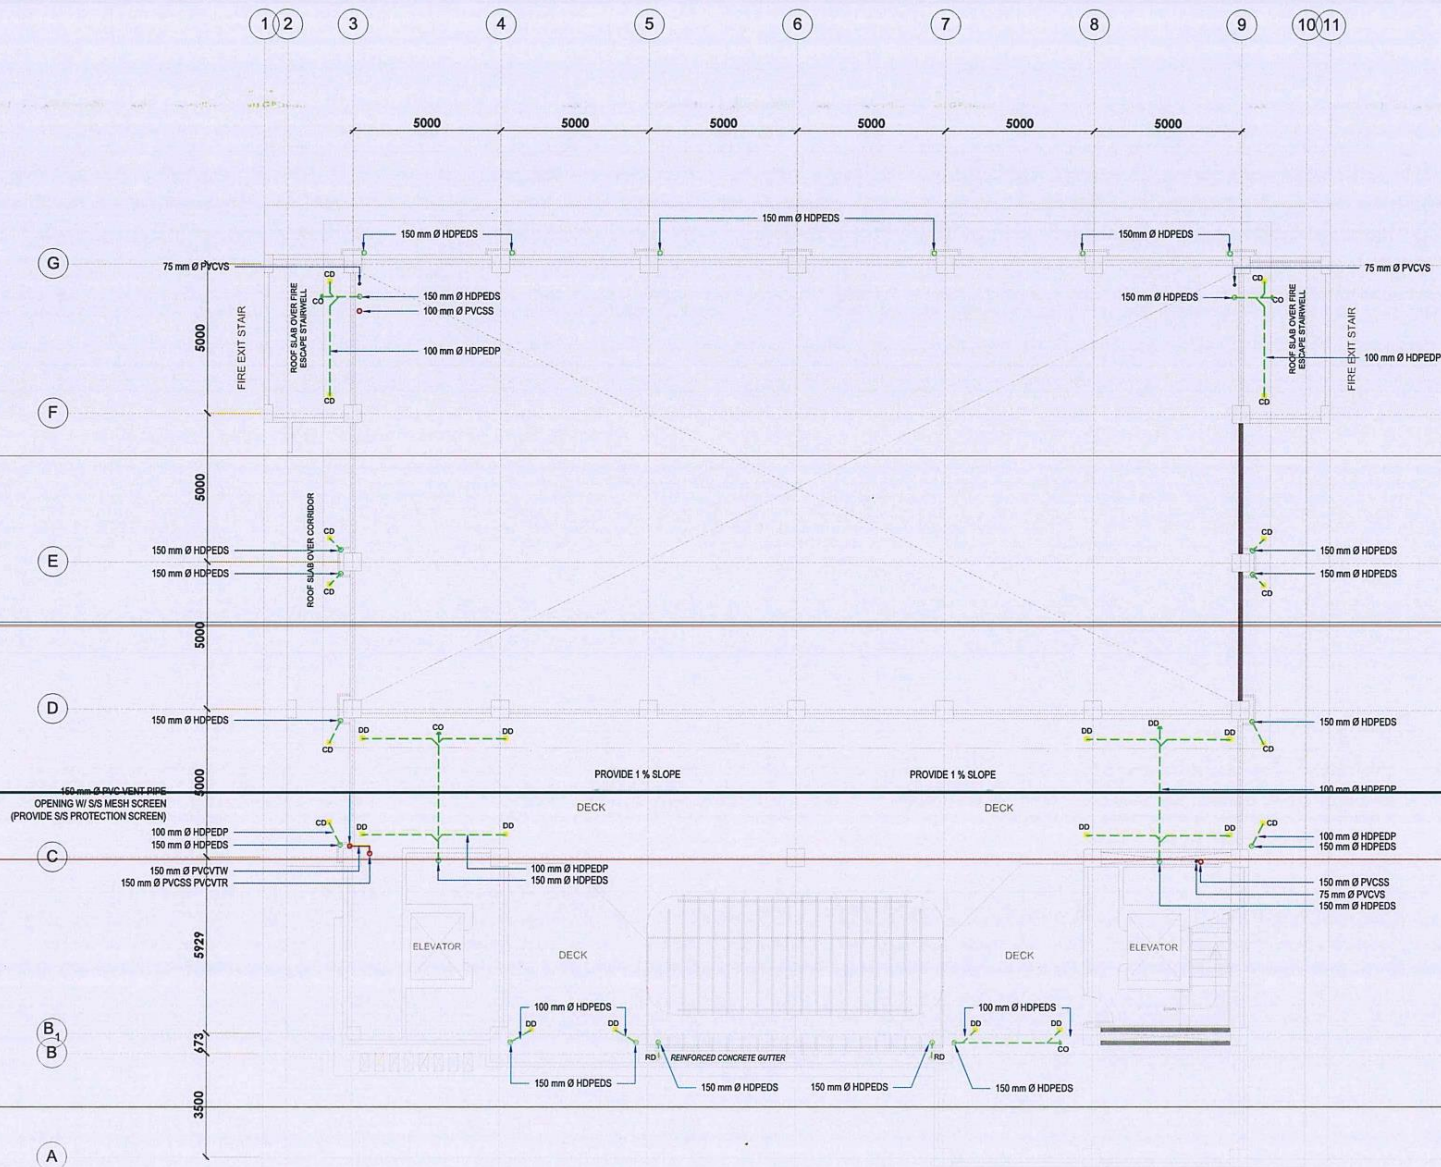

1  
 P-5  
**DECK ROOF PLAN (SEWER AND DRAINAGE LAYOUT)**  
 SCALE  
 1 : 100 m.

